


LEGEND

- ⊗ Bulb light
- |—|— Fluorescent light 600mm
- ⬤ Power point double
- Light switch
- ▣ Switchboard
- - - - - Electrical cable

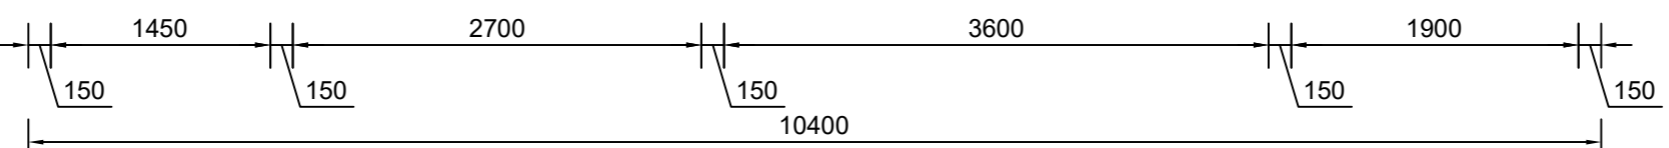

ELECTRICAL LAYOUT
Scale 1:50