

2 SITE 01  
S 1:1000



1 SITE  
S 1:500



**TDS**

TECHNICAL DESIGN SERVICES  
ARCHITECTURAL UNIT  
MINISTRY OF INFRASTRUCTURE &  
SUSTAINABLE ENERGY  
PO BOX 498  
BETIO, TARAWA  
REPUBLIC OF KIRIBATI  
PHONE: +686 75126192  
EMAIL: design@mise.gov.ki

MoE library Archives

CLIENT: MoE  
PROJECT NO: 102201

DWG TITLE:  
SITE PLAN

DRAWN BY: Ioane P. Taboia  
REVIEWED BY: Barry M  
DATE: 29/06/22  
SCALE: As indicated


DRAWING NUMBER: ISSUE:

A01



DRAWING LIST

000	COVER PAGE
A01	SITE PLAN
A02	LAYOUT PLANS
A03	LAYOUT PLANS
A50	SECTIONS
A100	ELEVATIONS
A200	DETAILS
A250	DETAILS - WALL REINFORCEMENT
A251	DETAILS - DRAINAGE LAYOUT
A252	DETAILS - DISTRIBUTION CHAMBER
A300	WINDOW SCHEDULE
A301	DOOR SCHEDULE
A302	SCHEDULE

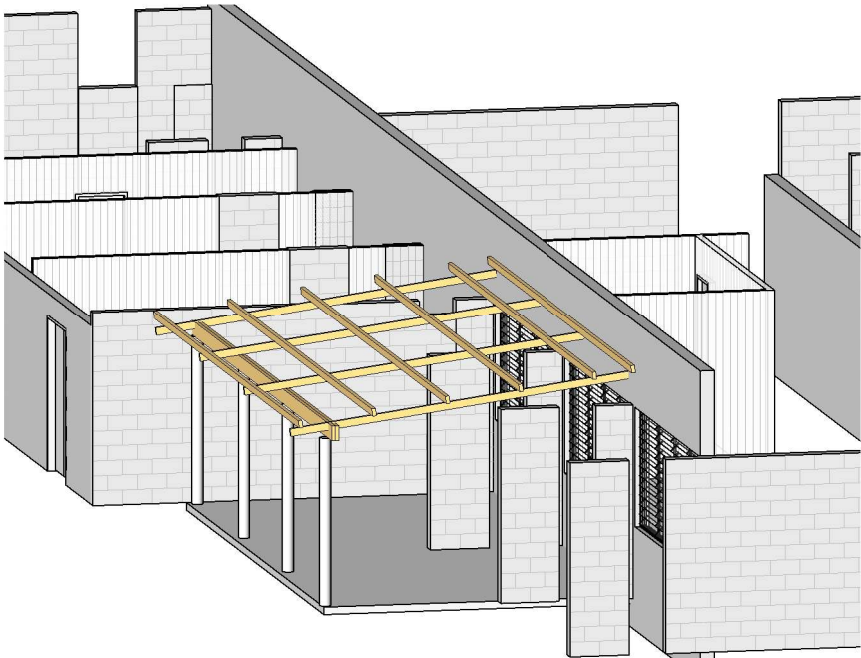

1 {3D}  
s



TDS

TECHNICAL DESIGN SERVICES  
ARCHITECTURAL UNIT  
MINISTRY OF INFRASTRUCTURE &  
SUSTAINABLE ENERGY  
PO BOX 498  
BETIO, TARAWA  
REPUBLIC OF KIRIBATI  
PHONE: +686 75126192  
EMAIL: design@mise.gov.ki

MoE library Archives


CLIENT: MoE  
PROJECT NO: 102201

DWG TITLE:  
COVER PAGE

DRAWN BY: Author  
REVIEWED BY: Checker  
DATE: 12/21/15  
SCALE:

DRAWING NUMBER: ISSUE:

000

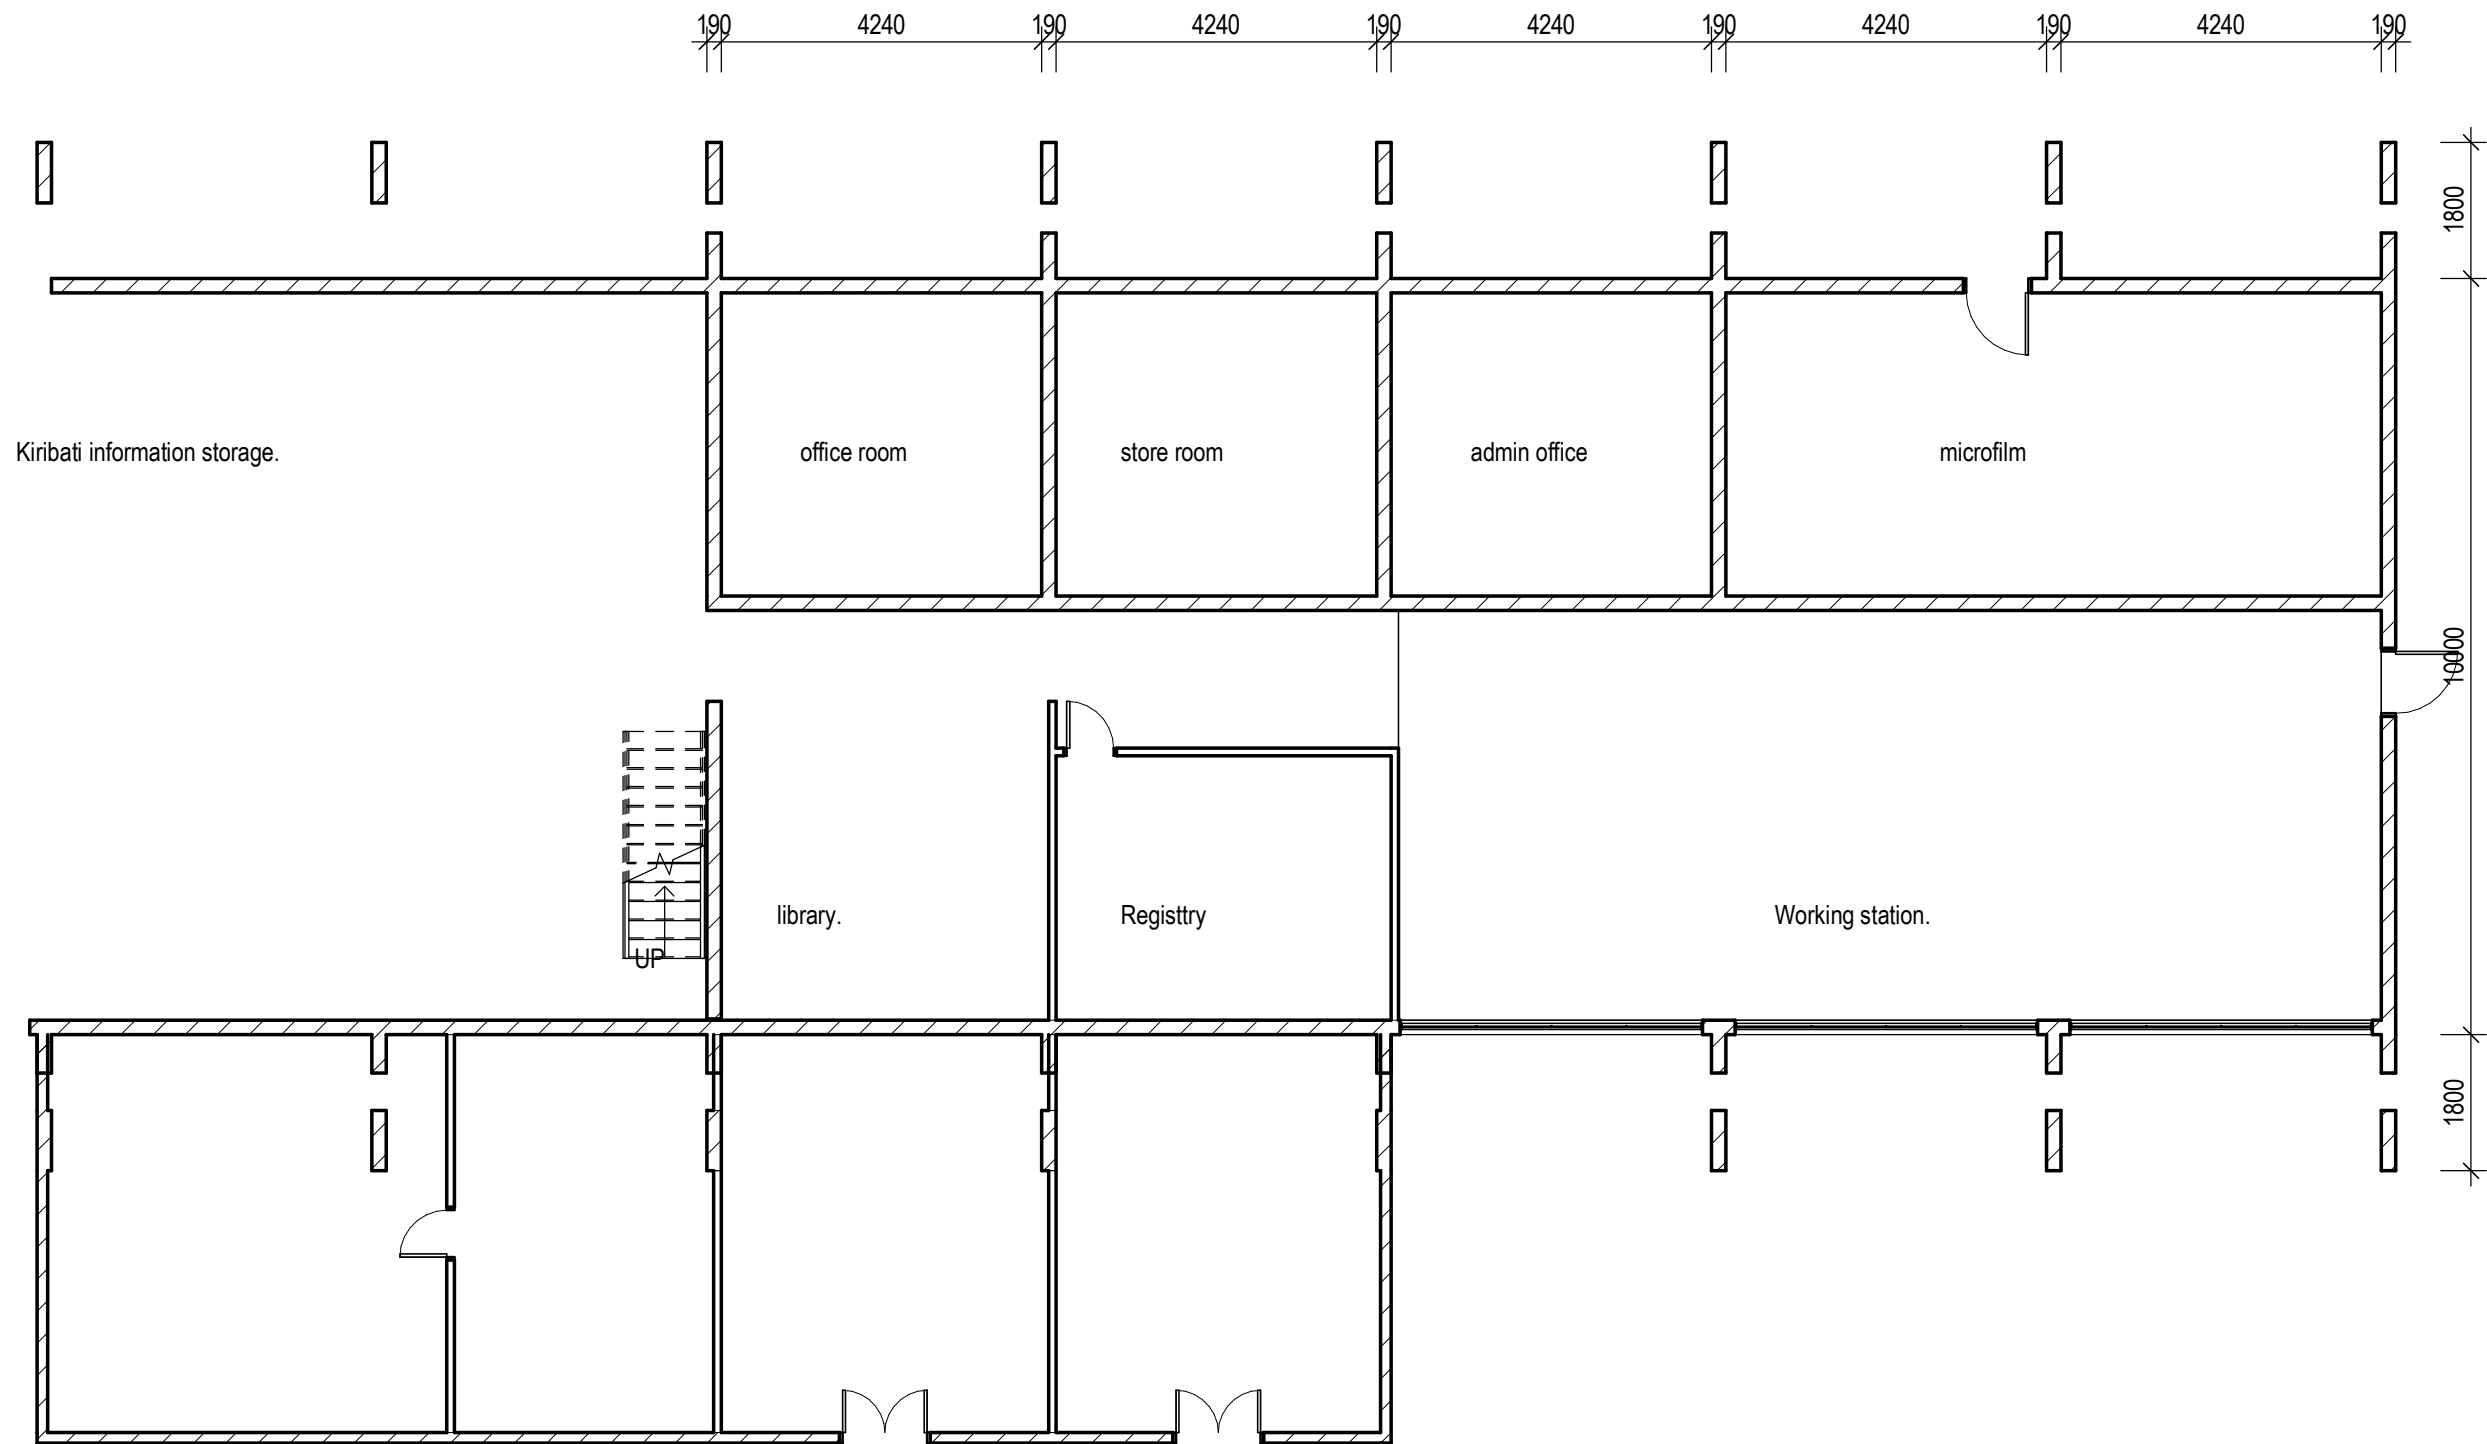

1 EXISTING PLAN  
S 1 : 100

**ADD**

TECHNICAL DESIGN SERVICES  
ARCHITECTURAL UNIT  
MINISTRY OF INFRASTRUCTURE &  
SUSTAINABLE ENERGY  
PO BOX 498  
BETIO, TARAWA  
REPUBLIC OF KIRIBATI  
PHONE: +686 75126192  
EMAIL: design@mise.gov.ki

**MoE library Archives**


CLIENT: MoE  
PROJECT NO: 102201

DWG TITLE:  
**LAYOUT PLANS**

DRAWN BY: Author  
REVIEWED BY: Checker  
DATE: 12/02/15  
SCALE: 1 : 100

DRAWING NUMBER: ISSUE:

**A02**

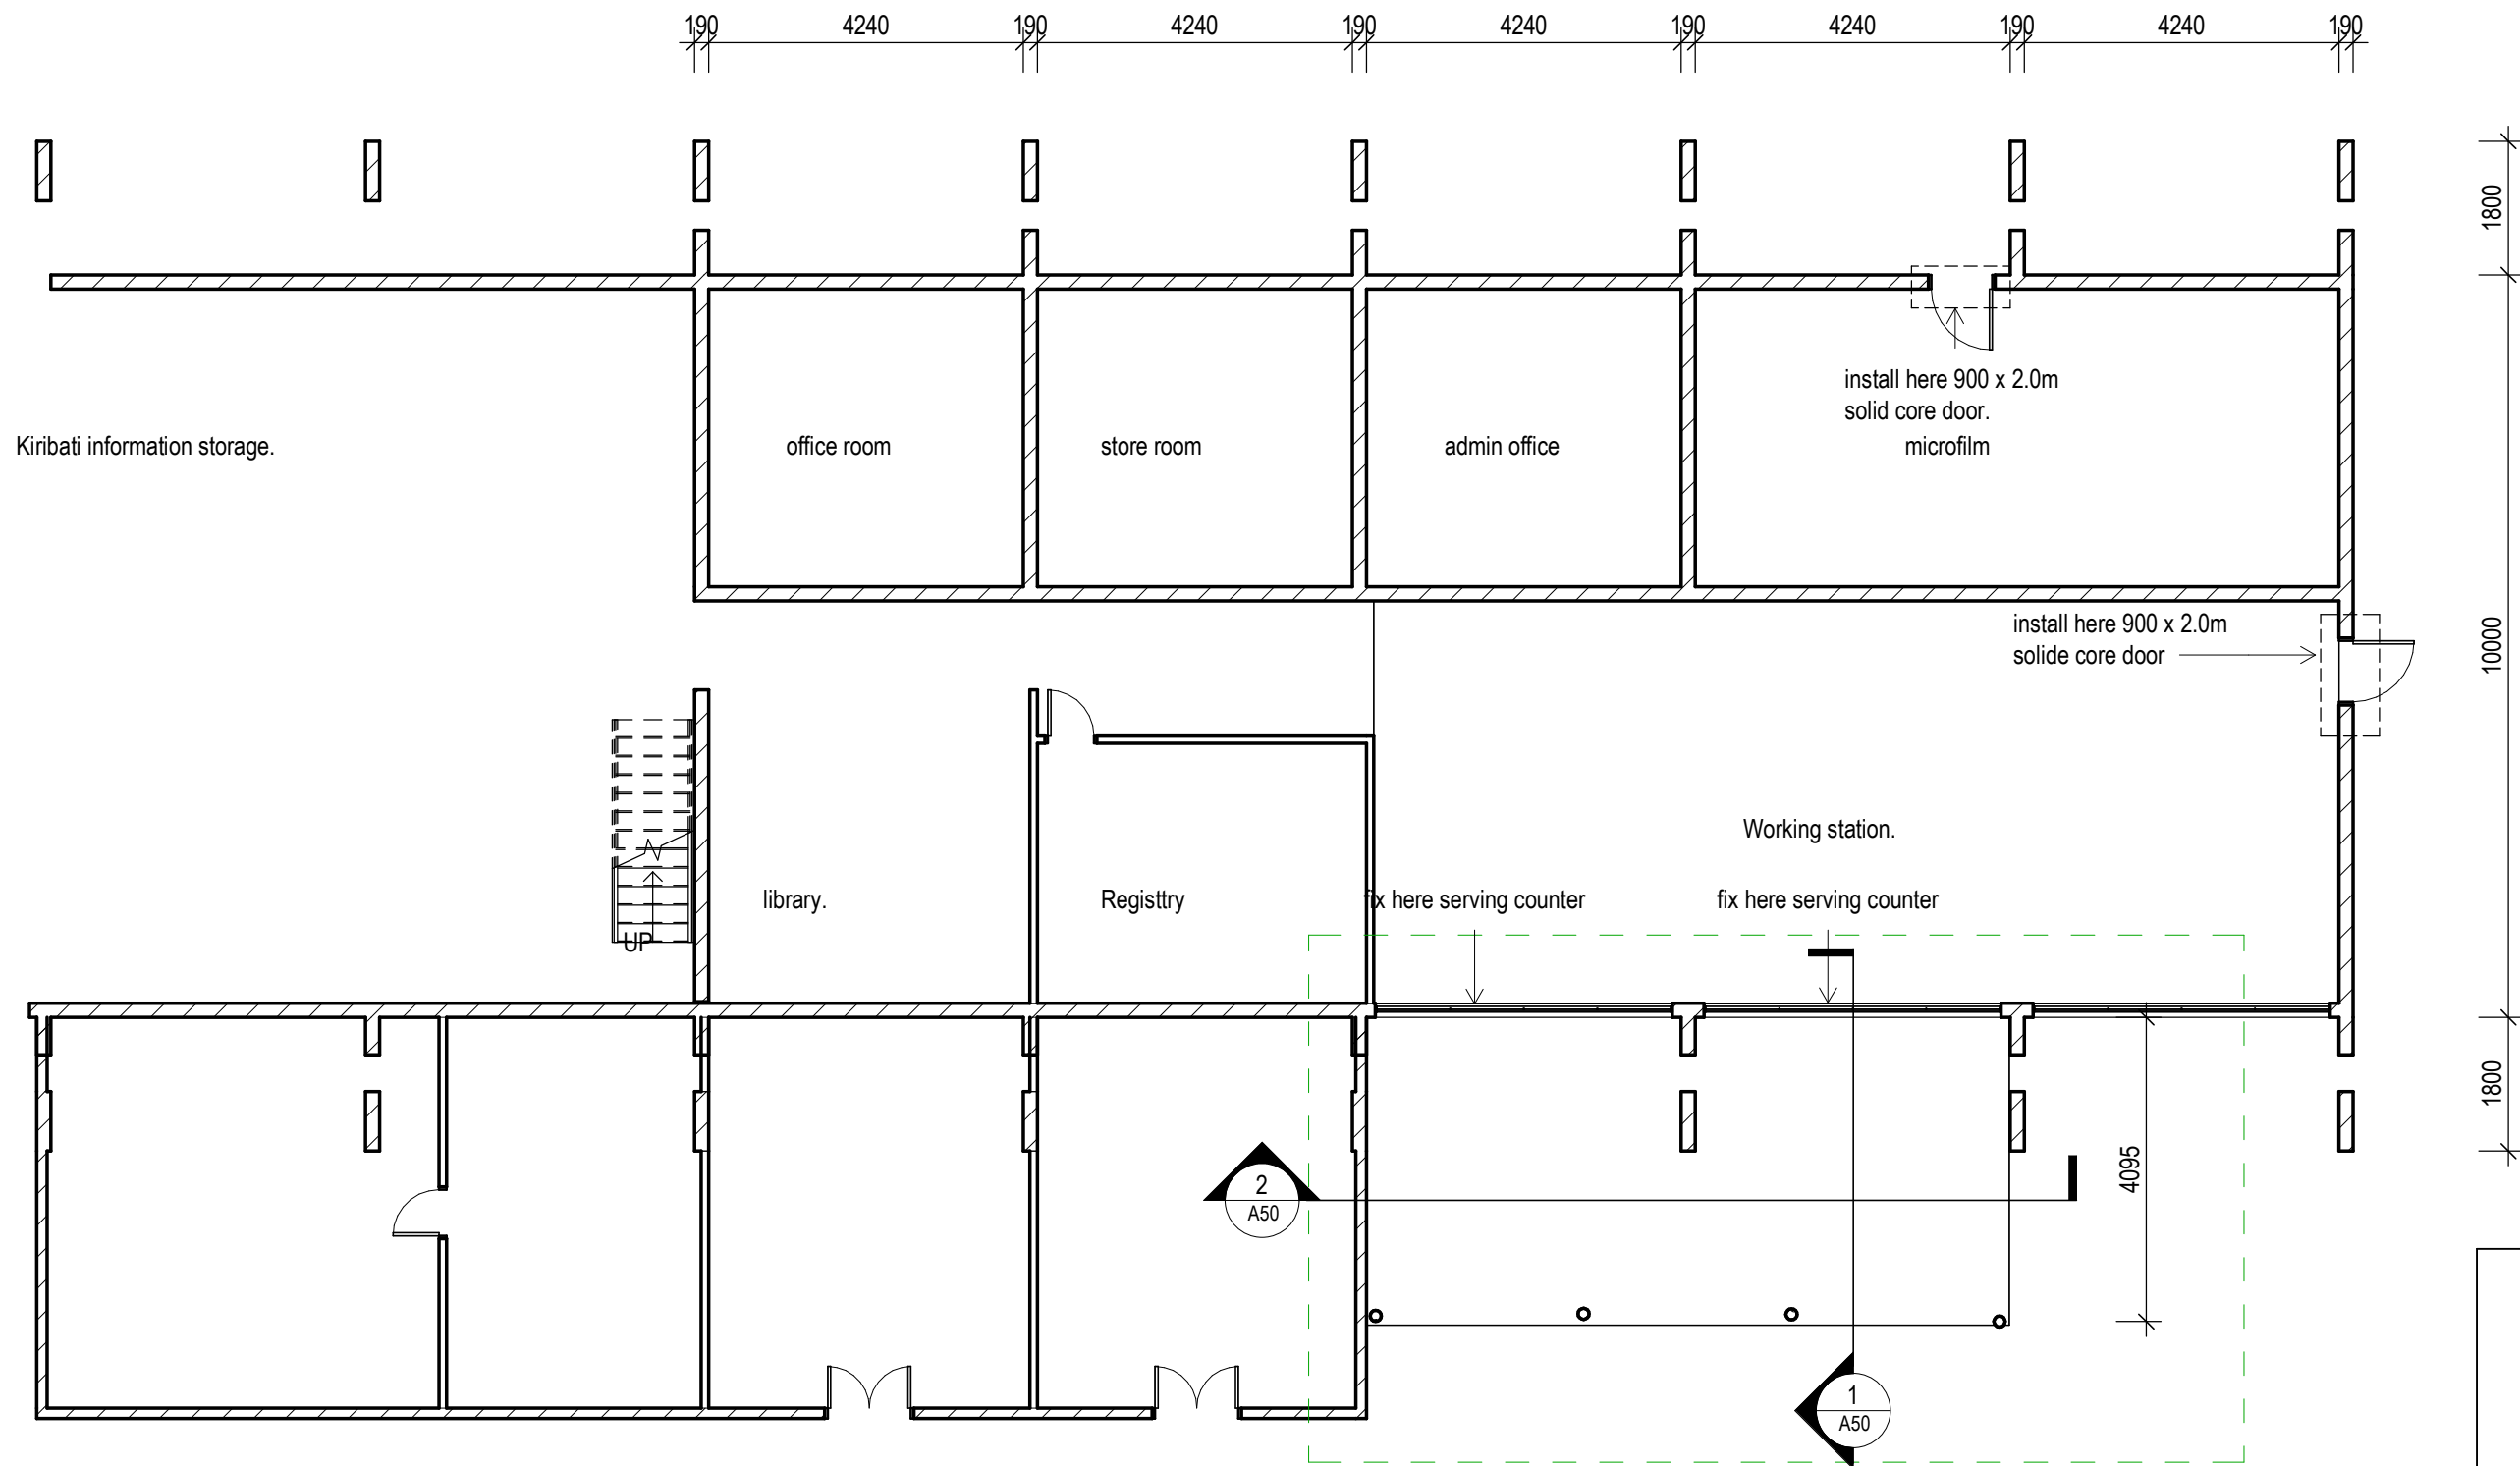

1 PROPOSED PLAN  
S 1:100

**ADD**  
TECHNICAL DESIGN SERVICES  
ARCHITECTURAL UNIT  
MINISTRY OF INFRASTRUCTURE &  
SUSTAINABLE ENERGY  
PO BOX 498  
BETIO, TARAWA  
REPUBLIC OF KIRIBATI  
PHONE: +686 75126192  
EMAIL: design@mise.gov.ki

MoE library Archives



CLIENT: MoE  
PROJECT NO: 102201

DWG TITLE:  
LAYOUT PLANS


DRAWN BY: Author  
REVIEWED BY: Checker  
DATE: 12/02/15  
SCALE: 1:100

DRAWING NUMBER: ISSUE:

A03

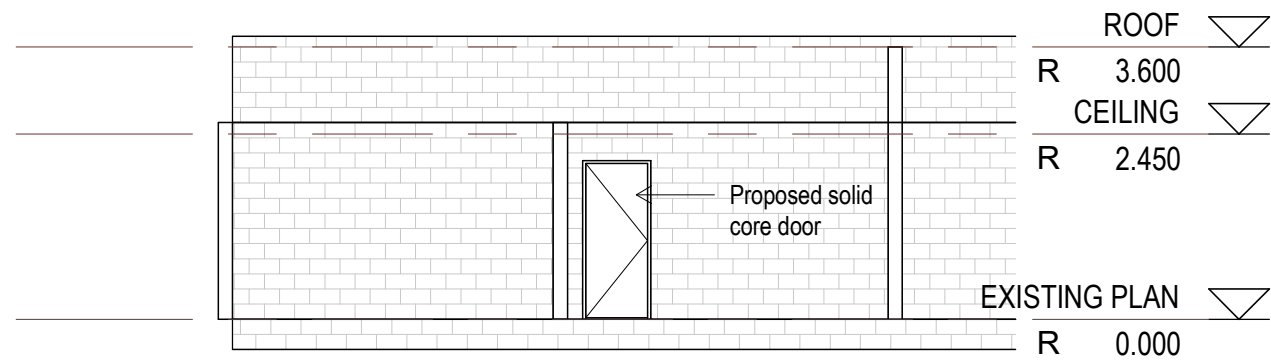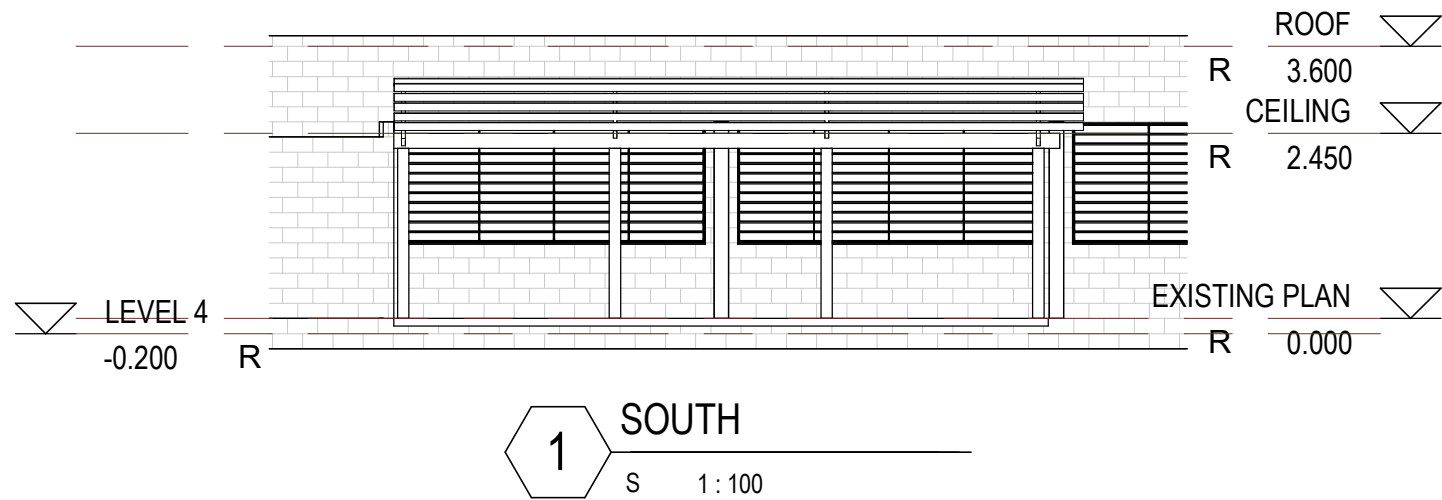

2 NORTH  
S 1:100

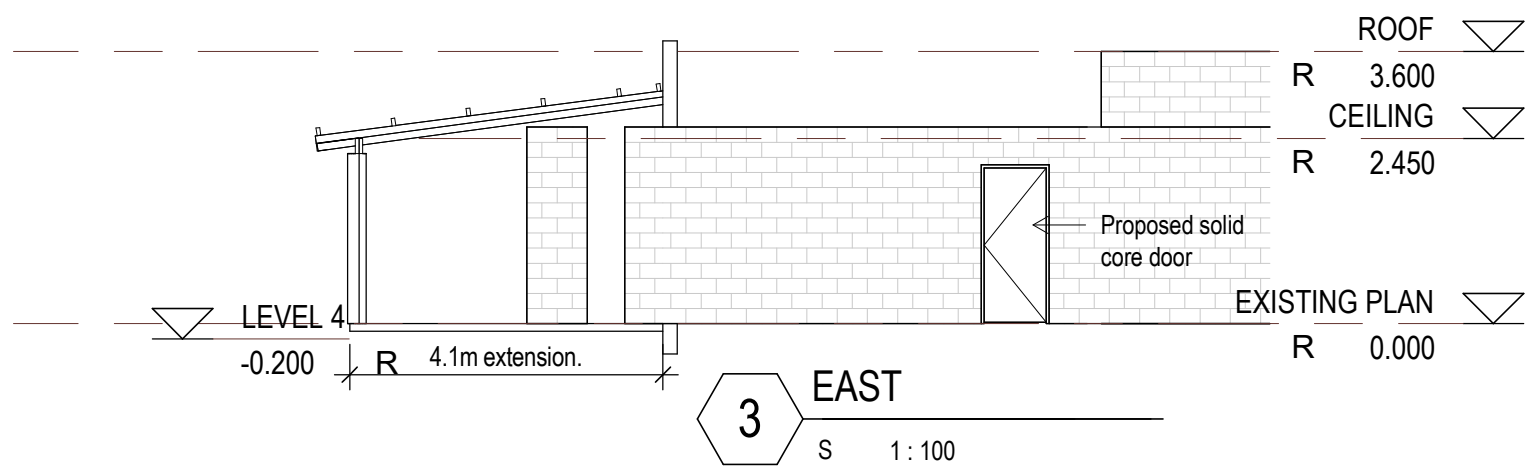

**ADD**

TECHNICAL DESIGN SERVICES  
ARCHITECTURAL UNIT  
MINISTRY OF INFRASTRUCTURE &  
SUSTAINABLE ENERGY  
PO BOX 498  
BETIO, TARAWA  
REPUBLIC OF KIRIBATI  
PHONE: +686 75126192  
EMAIL: design@mise.gov.ki

**MoE library Archives**



CLIENT: MoE  
PROJECT NO: 102201

DWG TITLE:  
**ELEVATIONS**

DRAWN BY: Author  
REVIEWED BY: Checker  
DATE: 12/02/15  
SCALE: 1:100

DRAWING NUMBER: ISSUE:

**A100**

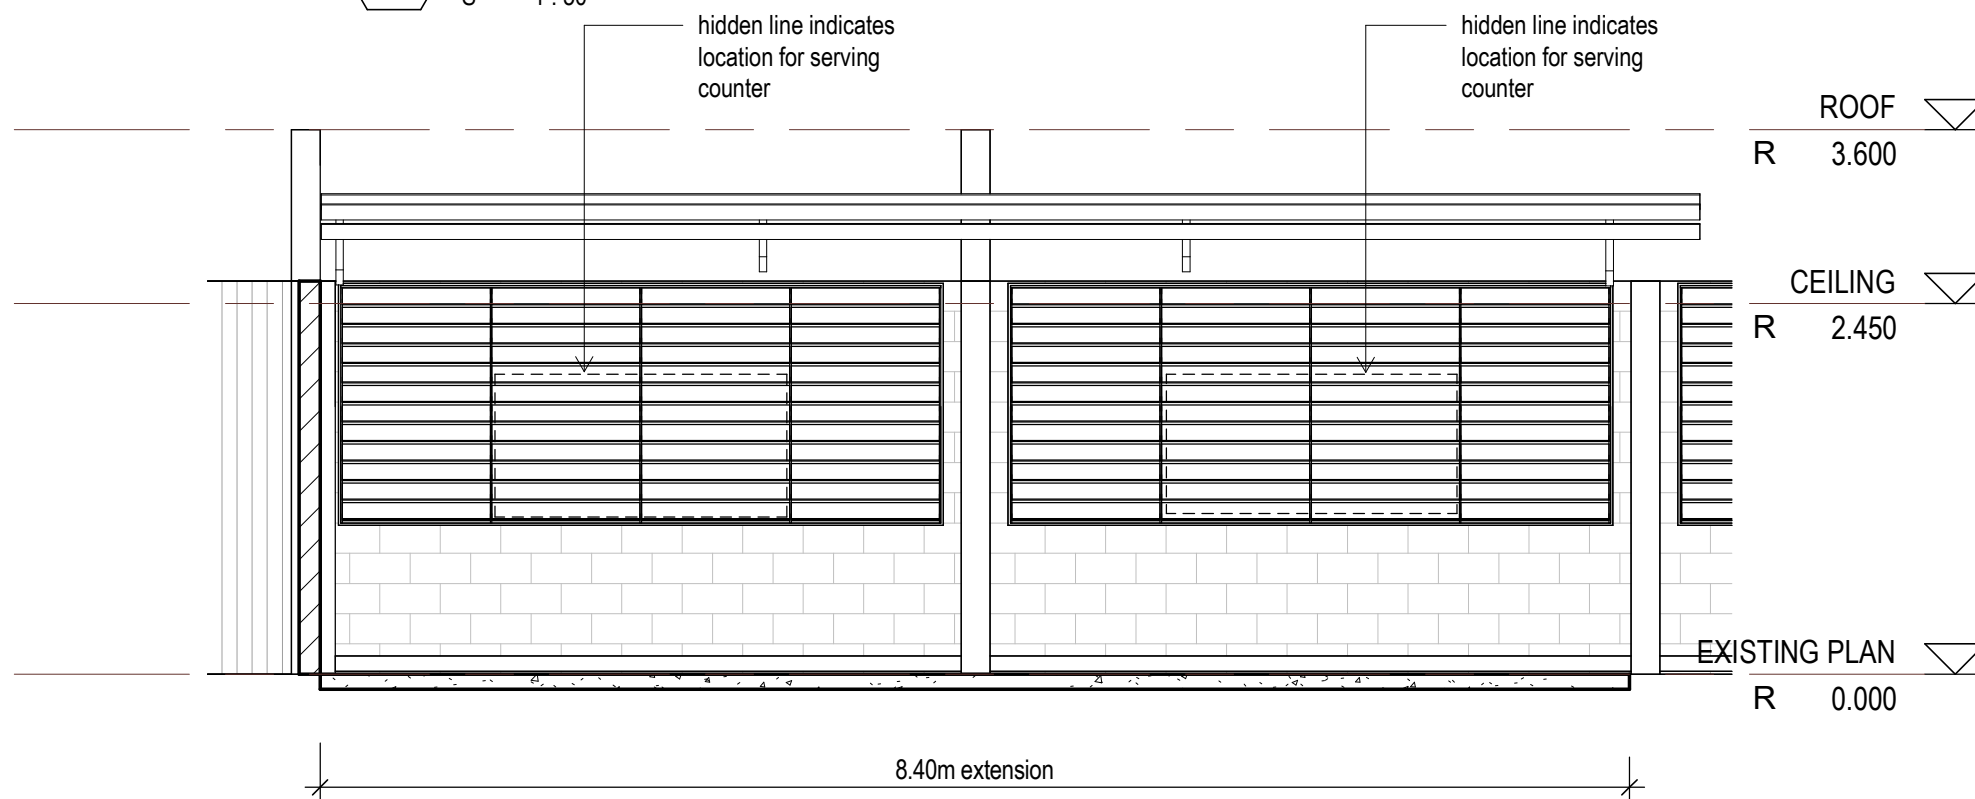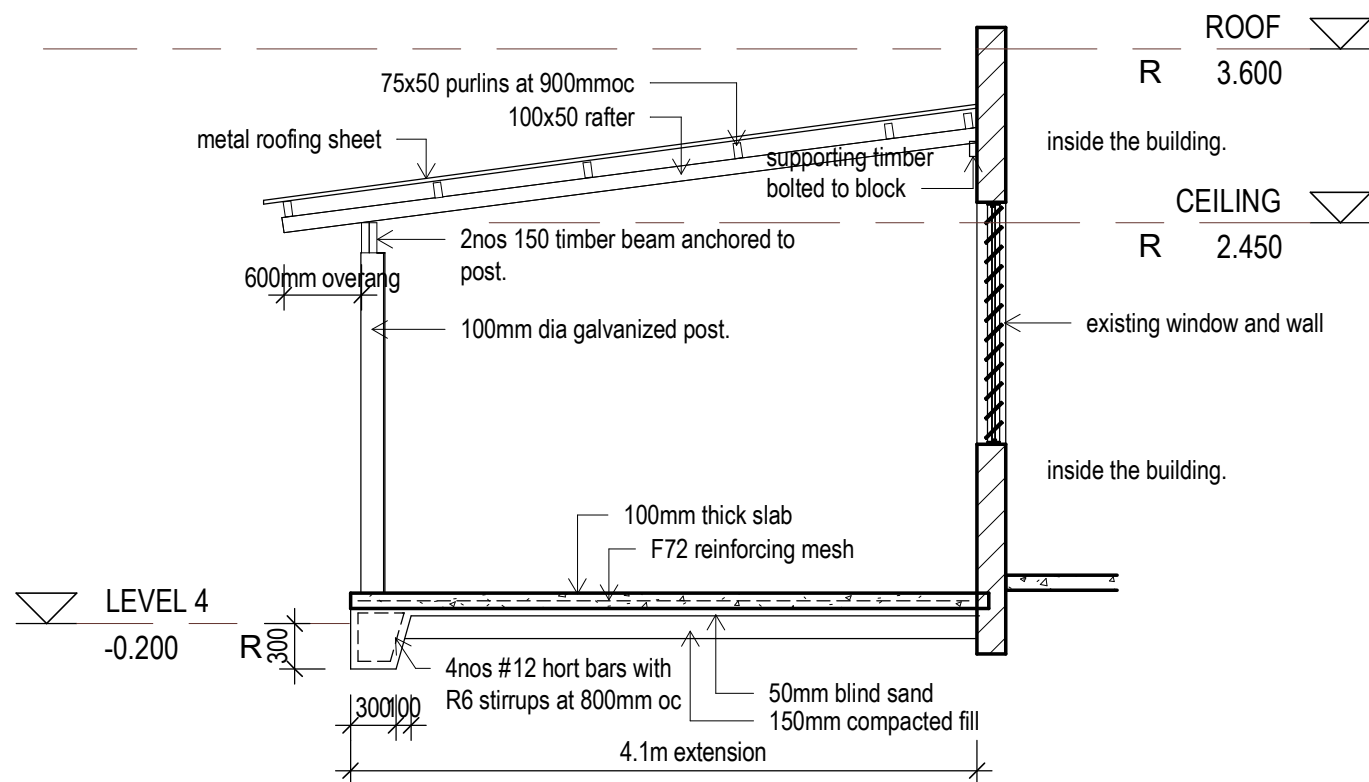

# ADD

TECHNICAL DESIGN SERVICES  
ARCHITECTURAL UNIT  
MINISTRY OF INFRASTRUCTURE &  
SUSTAINABLE ENERGY  
PO BOX 498  
BETIO, TARAWA  
REPUBLIC OF KIRIBATI  
PHONE: +686 75126192  
EMAIL: design@mise.gov.ki

**MoE library Archives**

CLIENT: MoE  
PROJECT NO: 102201

DWG TITLE:  
**SECTIONS**

DRAWN BY: Author  
REVIEWED BY: Checker  
DATE: 12/02/15  
SCALE: 1 : 50

DRAWING NUMBER: ISSUE:

**A50**

